


FIRE BRIGADE PRE-INCIDENT PLAN

Company: F-Plan GmbH

GROUND FLOOR PLAN

1/234

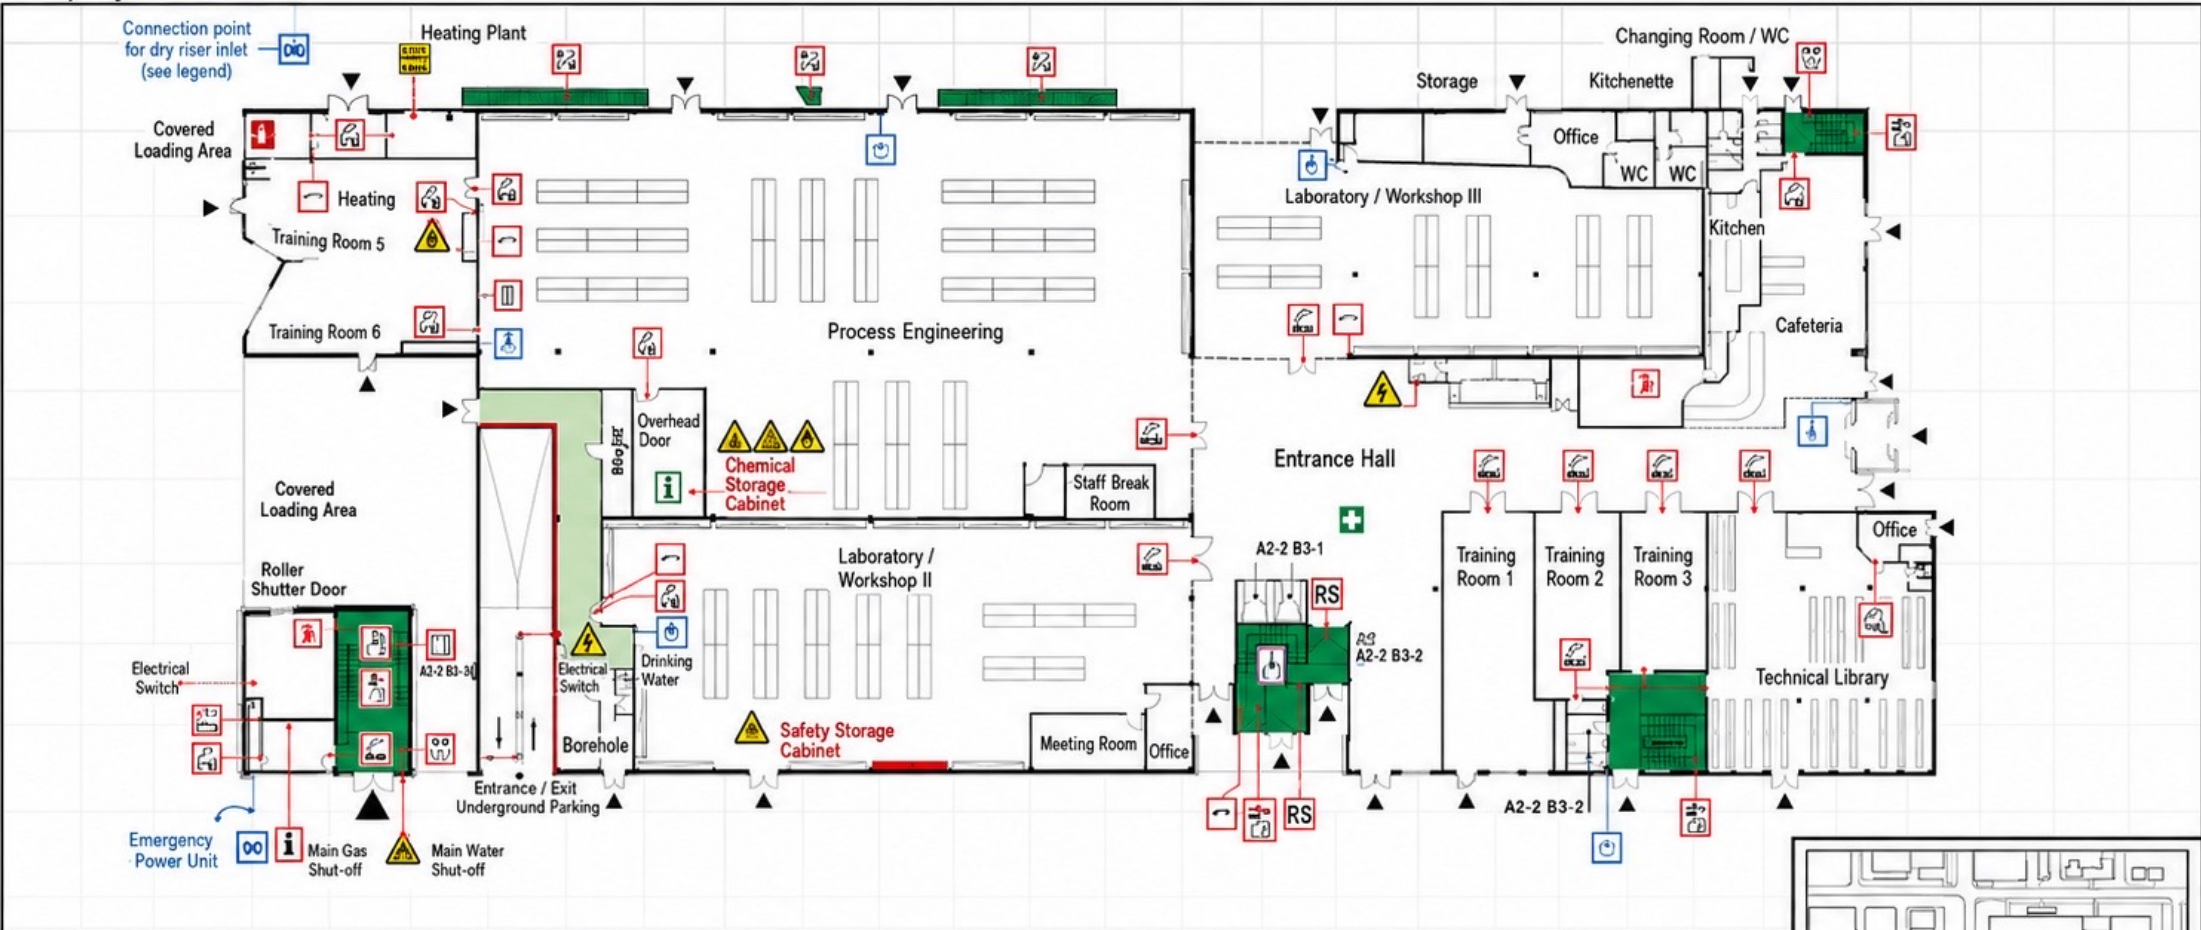

FIRE PROTECTION EQUIPMENT	EMERGENCY EQUIPMENT	HAZARDS	ESCAPE AND RESCUE	FIRE BRIGADE INFORMATION	UTILITIES
Fire extinguisher	First aid kit	Warning - Flammable substances	Escape route	Fire brigade access point	Water supply
Fire hose reel	Automated External Defibrillator (AED)	Warning - Oxidizing substances	Emergency exit	Fire brigade key box	Gas supply
Fire alarm manual call point	Emergency telephone	Warning - Toxic substances	Alternative escape route	Fire department information center	Electrical distribution
Automatic fire detector	Emergency shower	Warning - Corrosive substances	Assembly point	Fire alarm zone	Compressed air
Fire alarm control panel	Eye wash station	Warning - Explosive atmosphere	Refuge area	Fire compartment	Technical services
Fire brigade key safe		Warning - Electrical hazard	Fire brigade access	Smoke compartment	
Fire department information panel		Warning - Gas cylinders	Rescue route		
Dry riser inlet		Warning - Laser radiation			
Fire department access route					

North

0 5 m 10 m

Plan Title:
Fire Brigade Pre-Incident Plan – Ground Floor
Scale: 1:234 (Original drawing)
Revision / Status: 01/2011
Date: 01/2011
F-Plan GmbH
www.f-plan.de